


PRINCE GEORGE'S COMMUNITY COLLEGE
WESTPHALIA TRAINING CENTER

FIRE EVACUATION PLAN

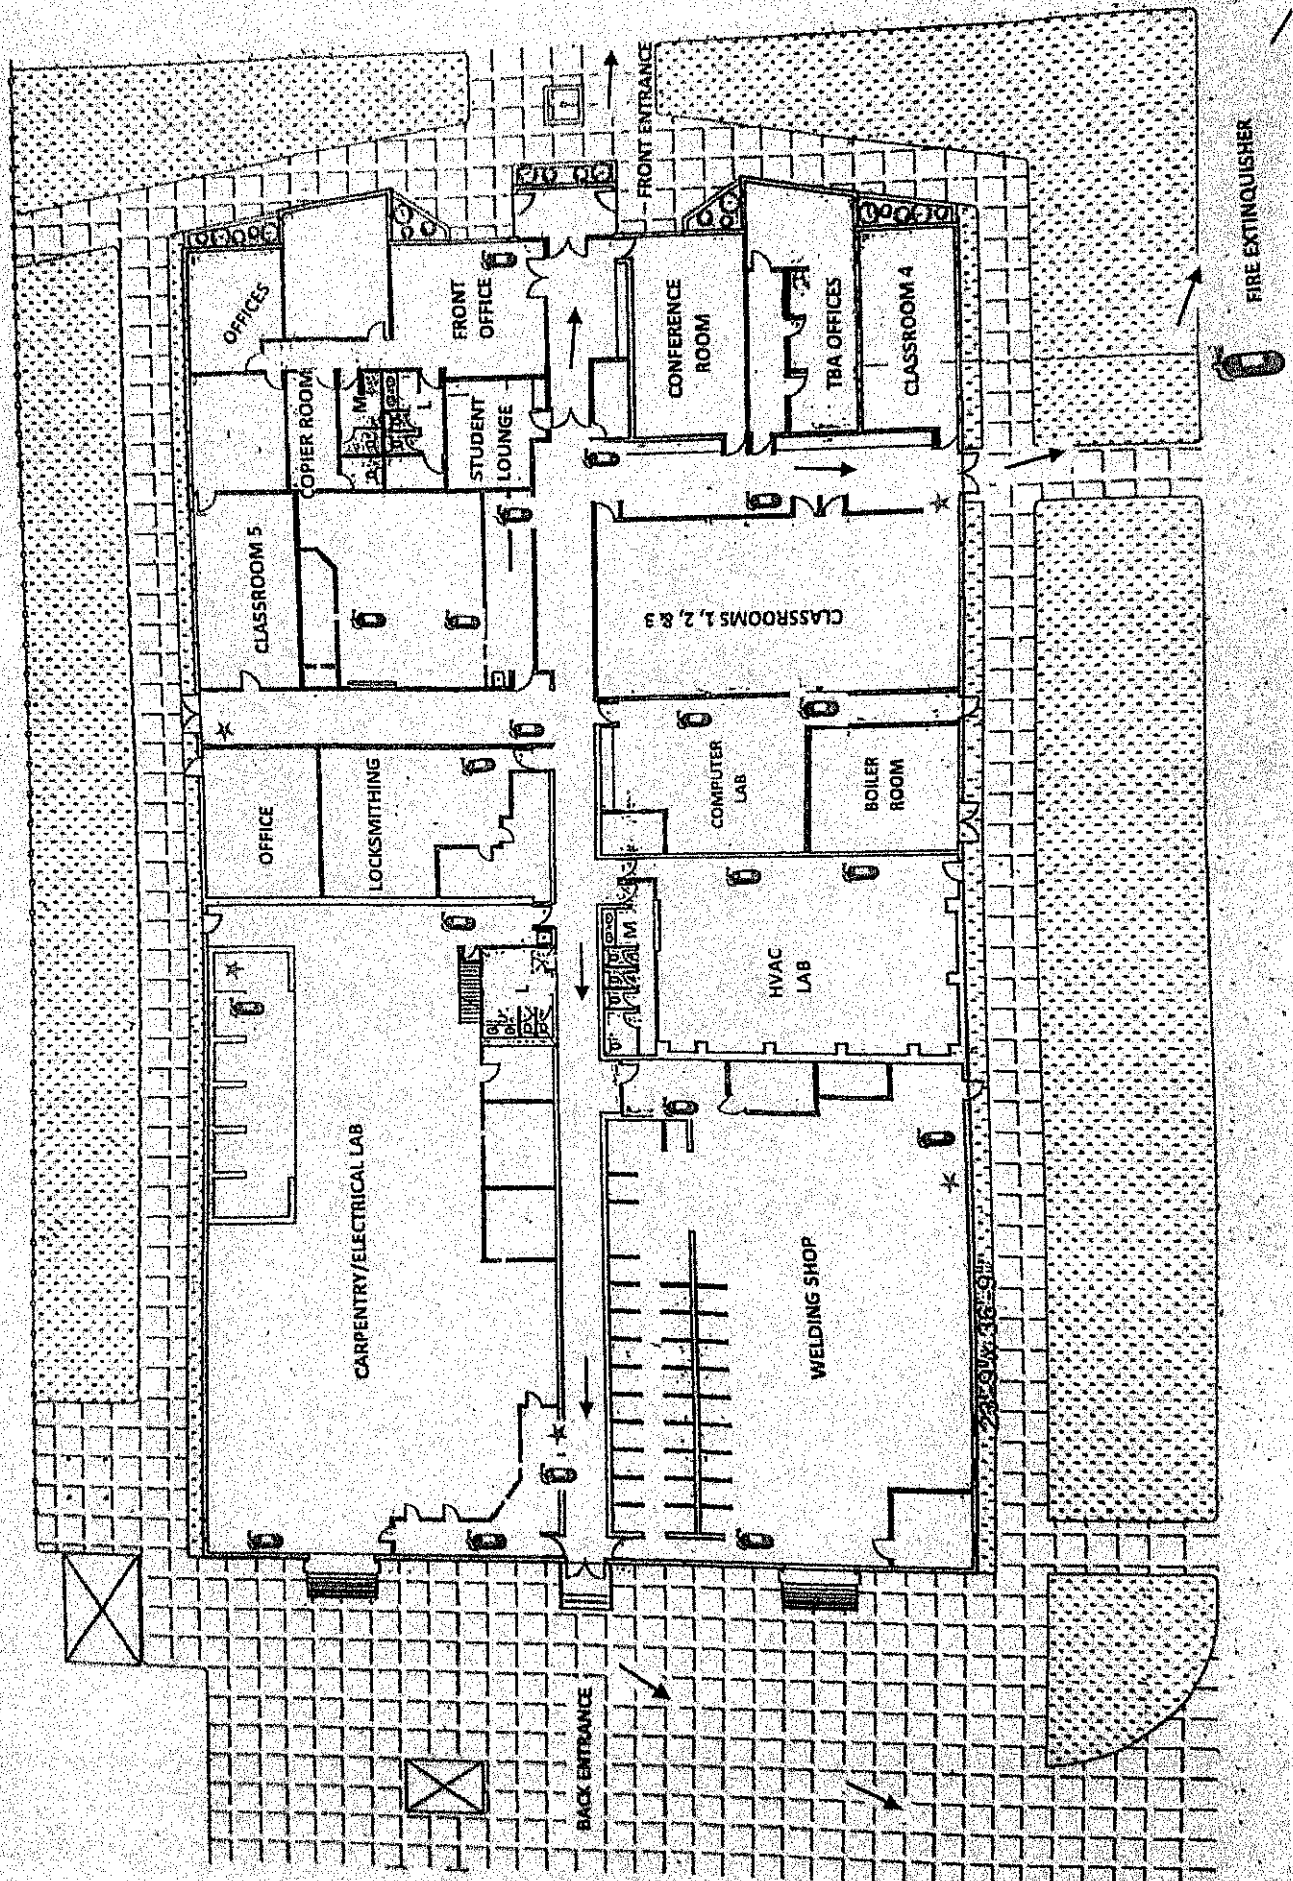

Skilled Trades Center Floor Plan Emergency Exits

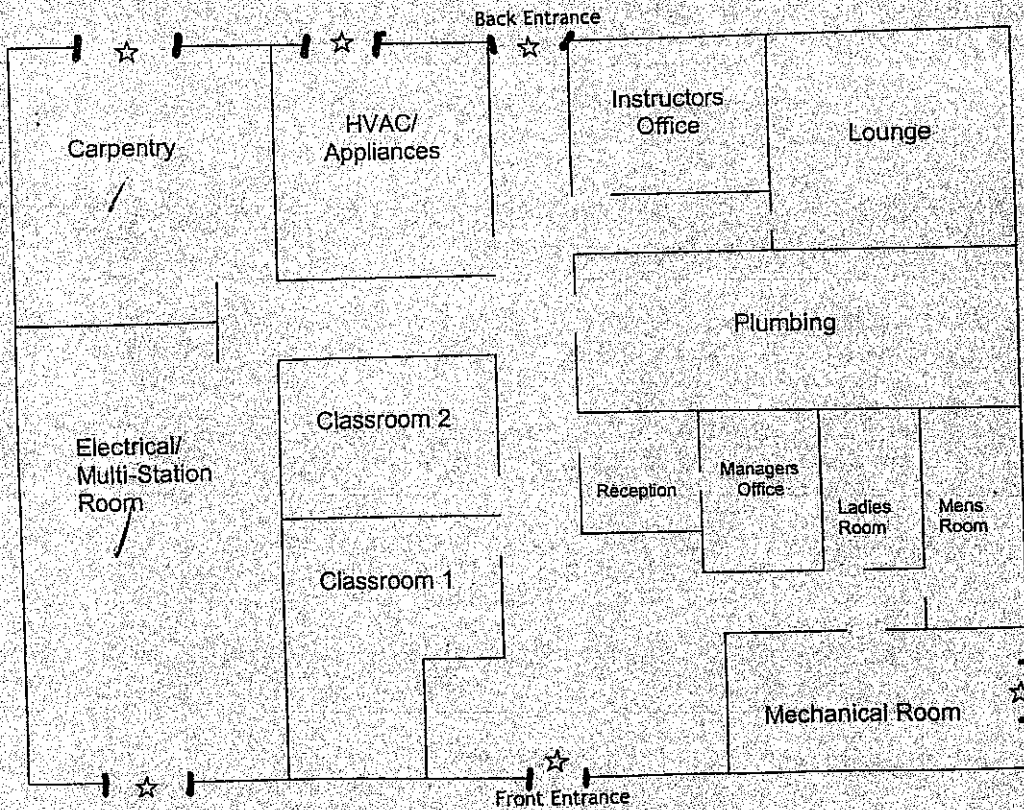


Figure 2.6
 Laurel College Center
Third Floor
 Scale: 1" = 16'

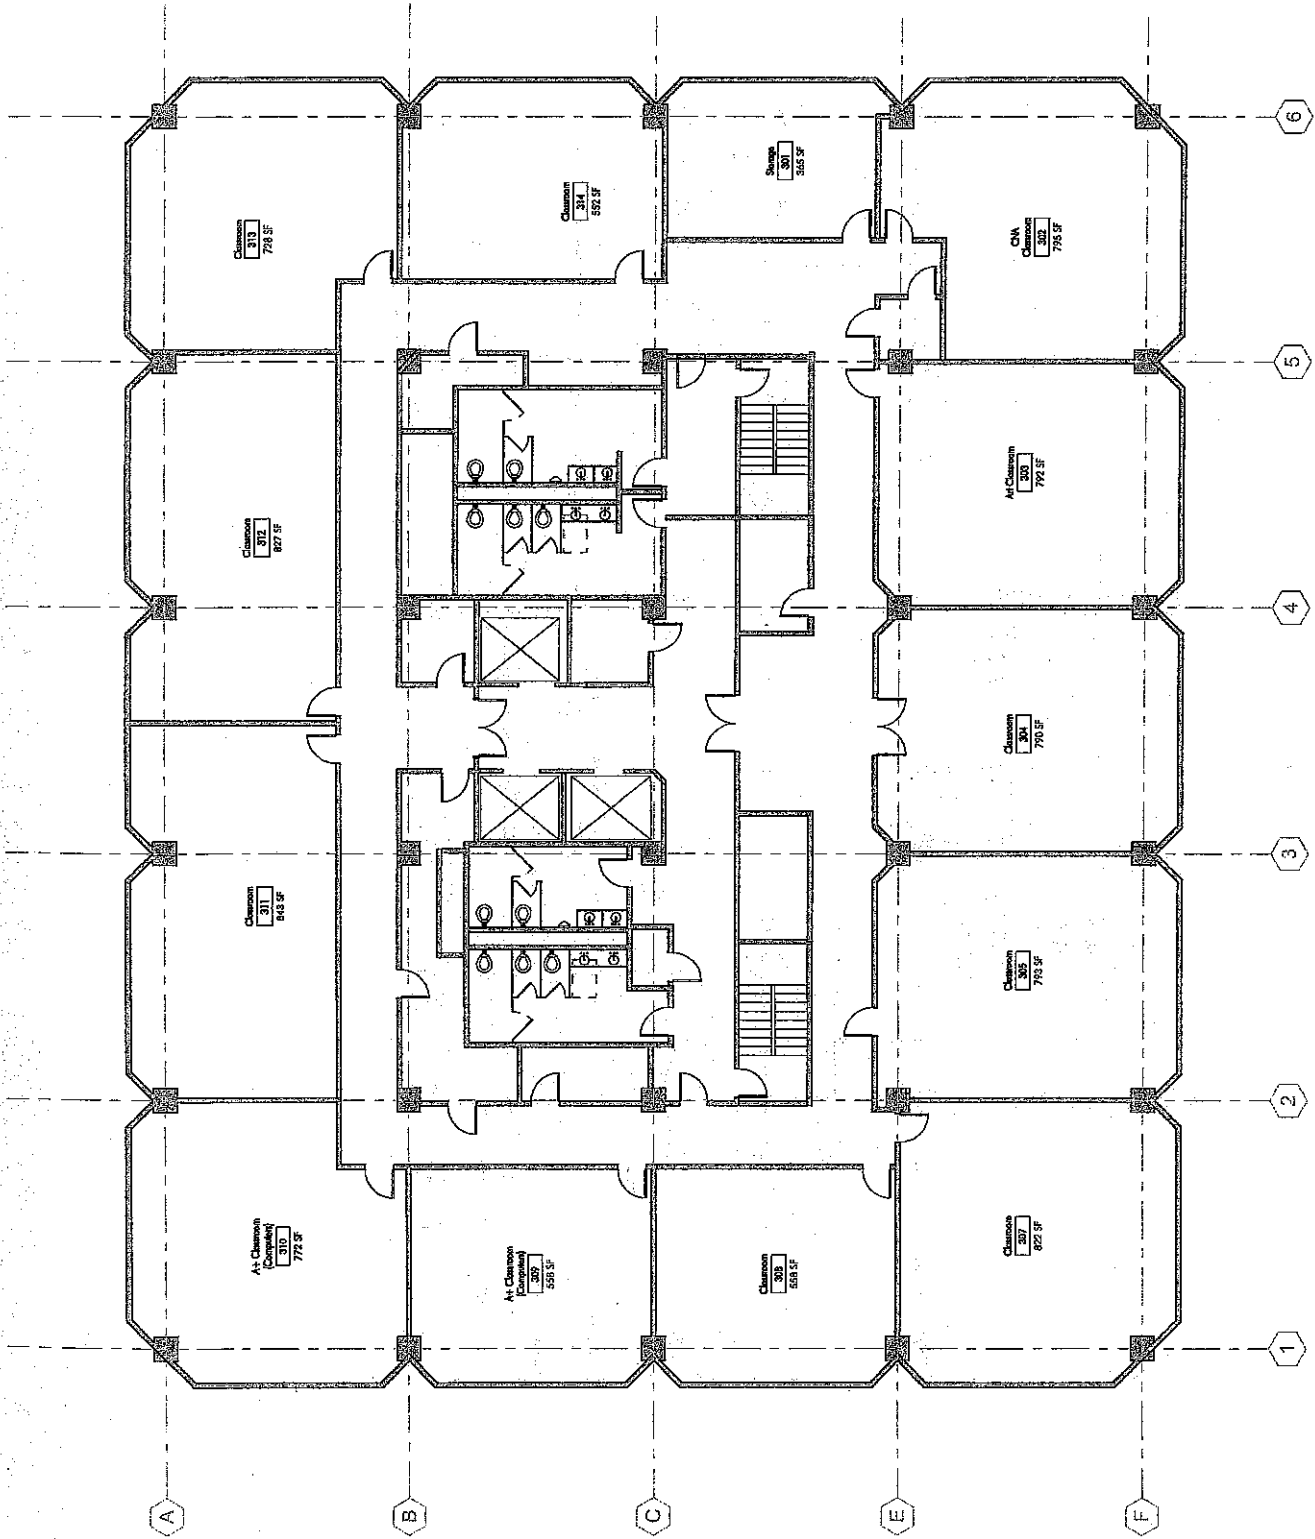


Figure 2.7
 Laurel College Center
Fourth Floor
 Scale: 1" = 16'

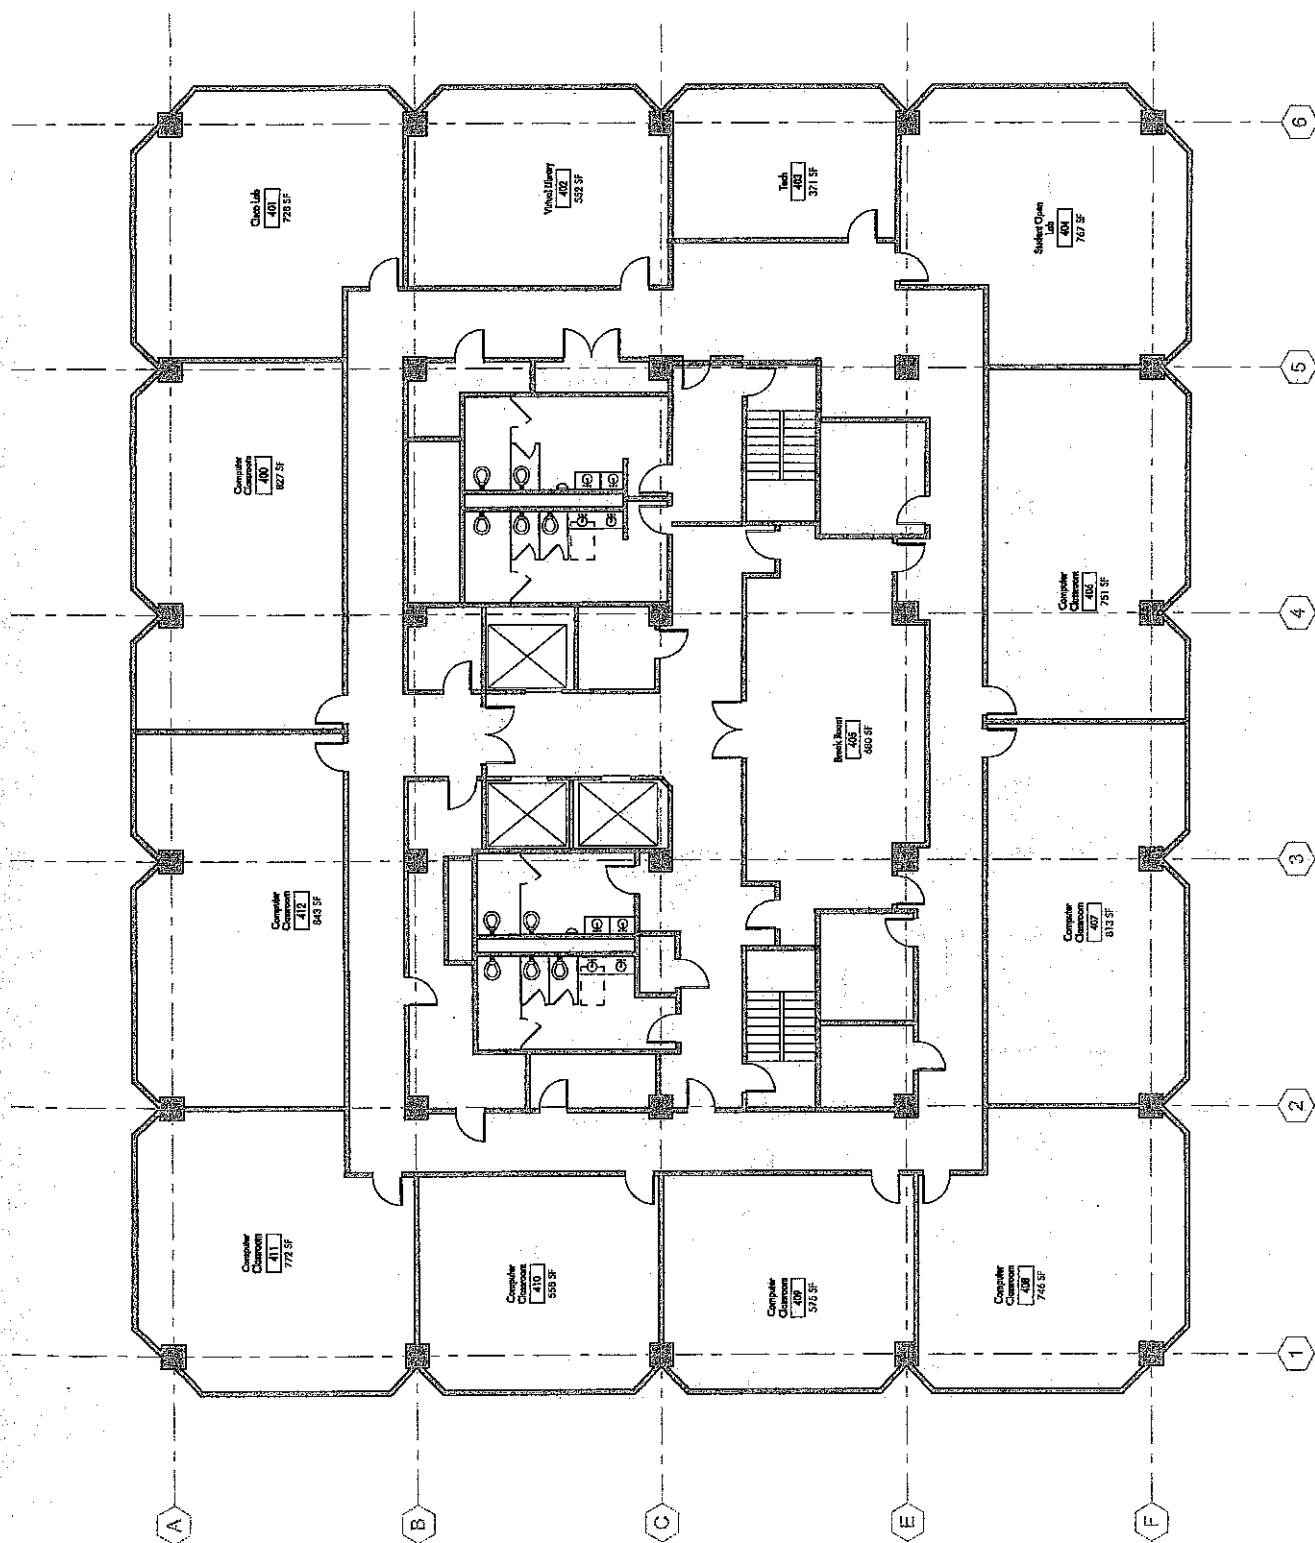


Figure 2.8
Laurel College Center
Fifth Floor
 Scale: 1" = 16'

